


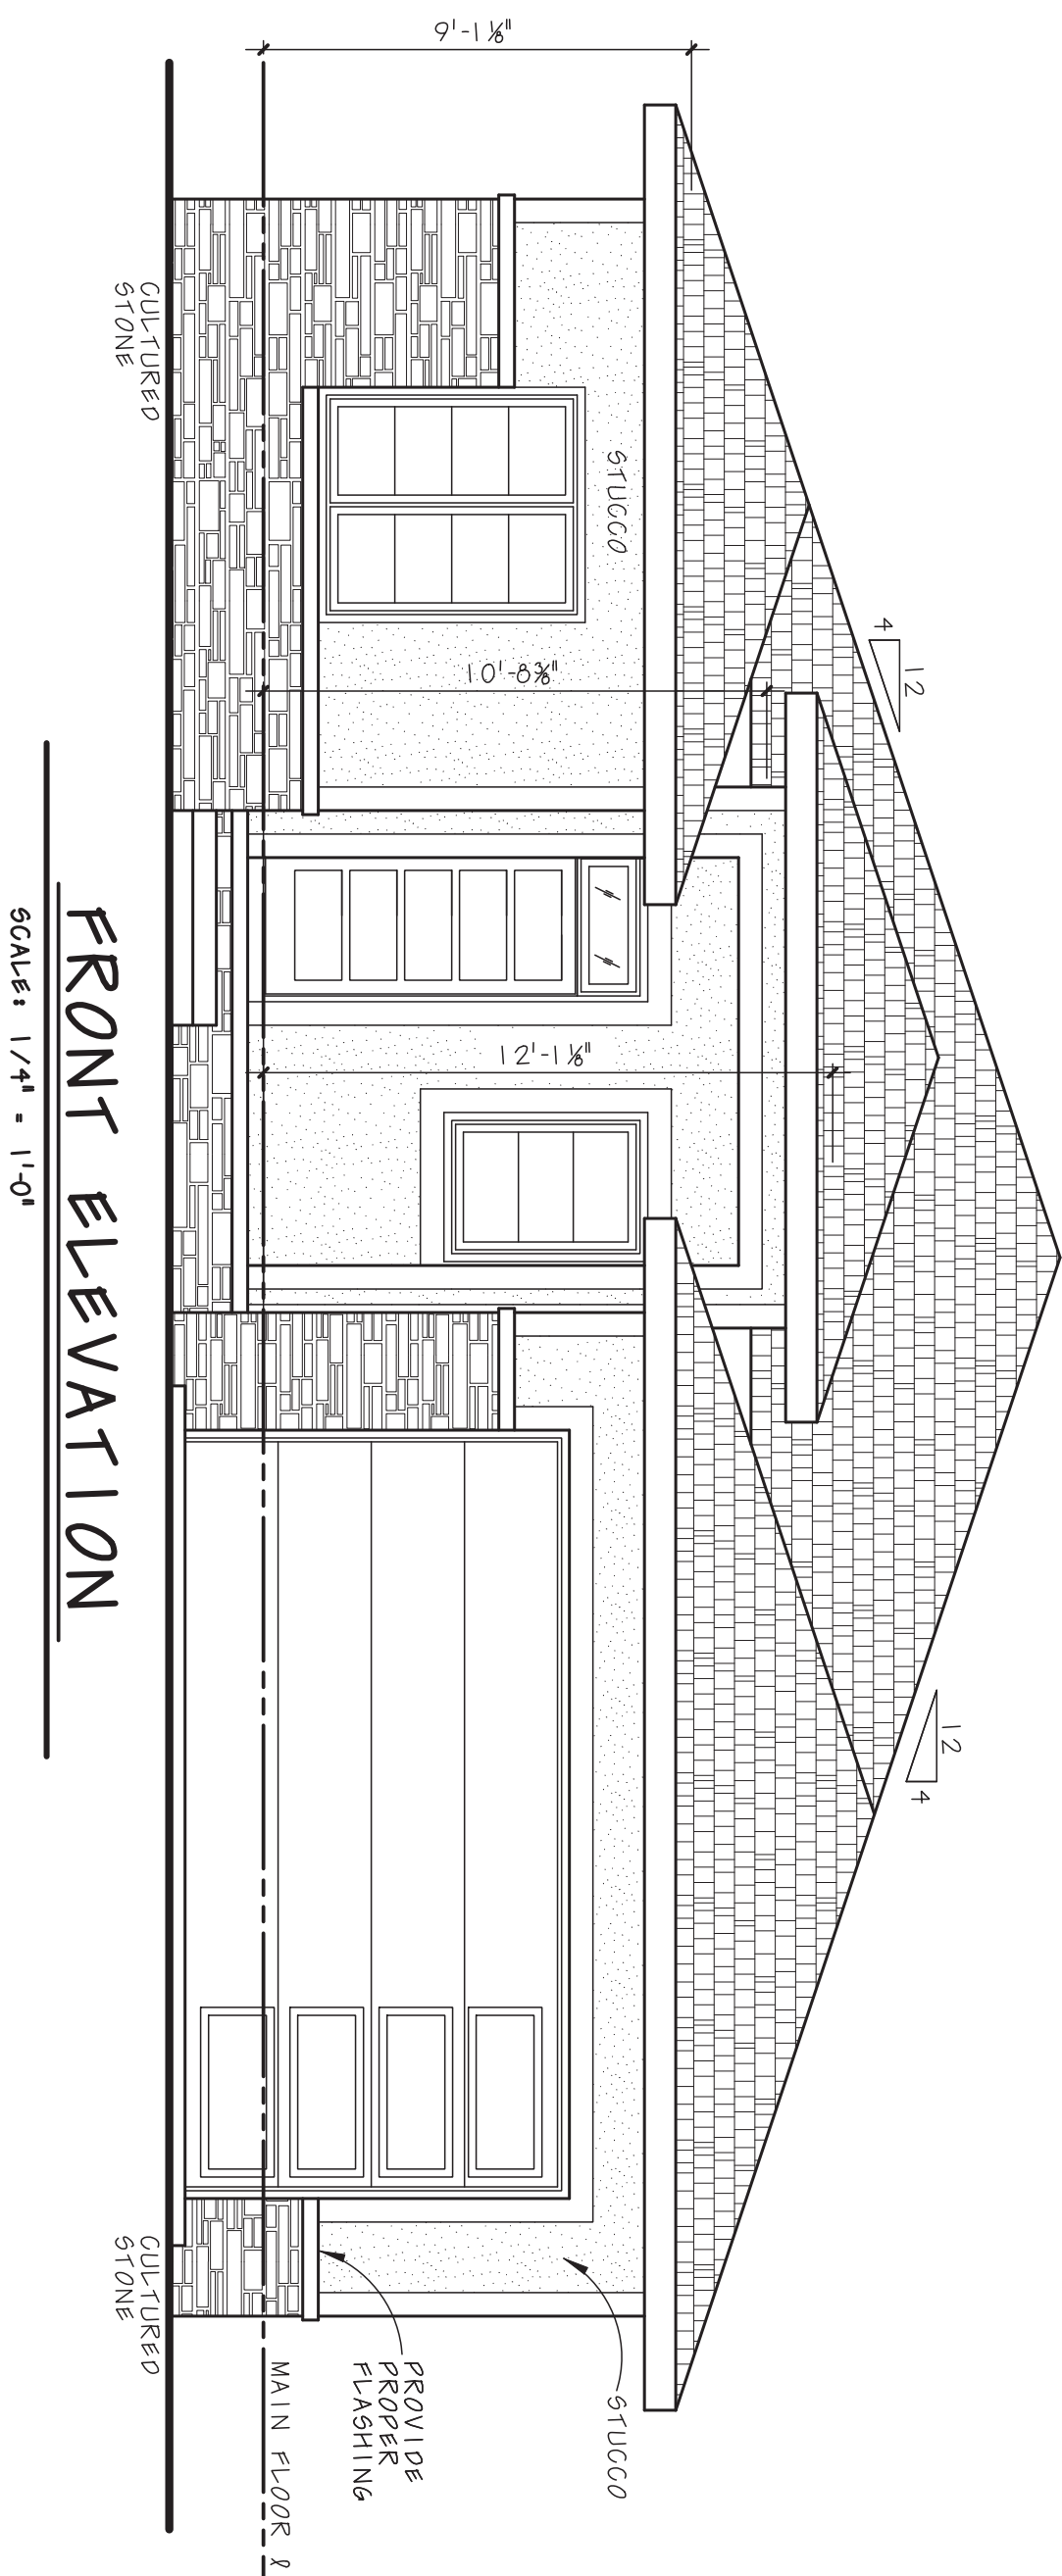
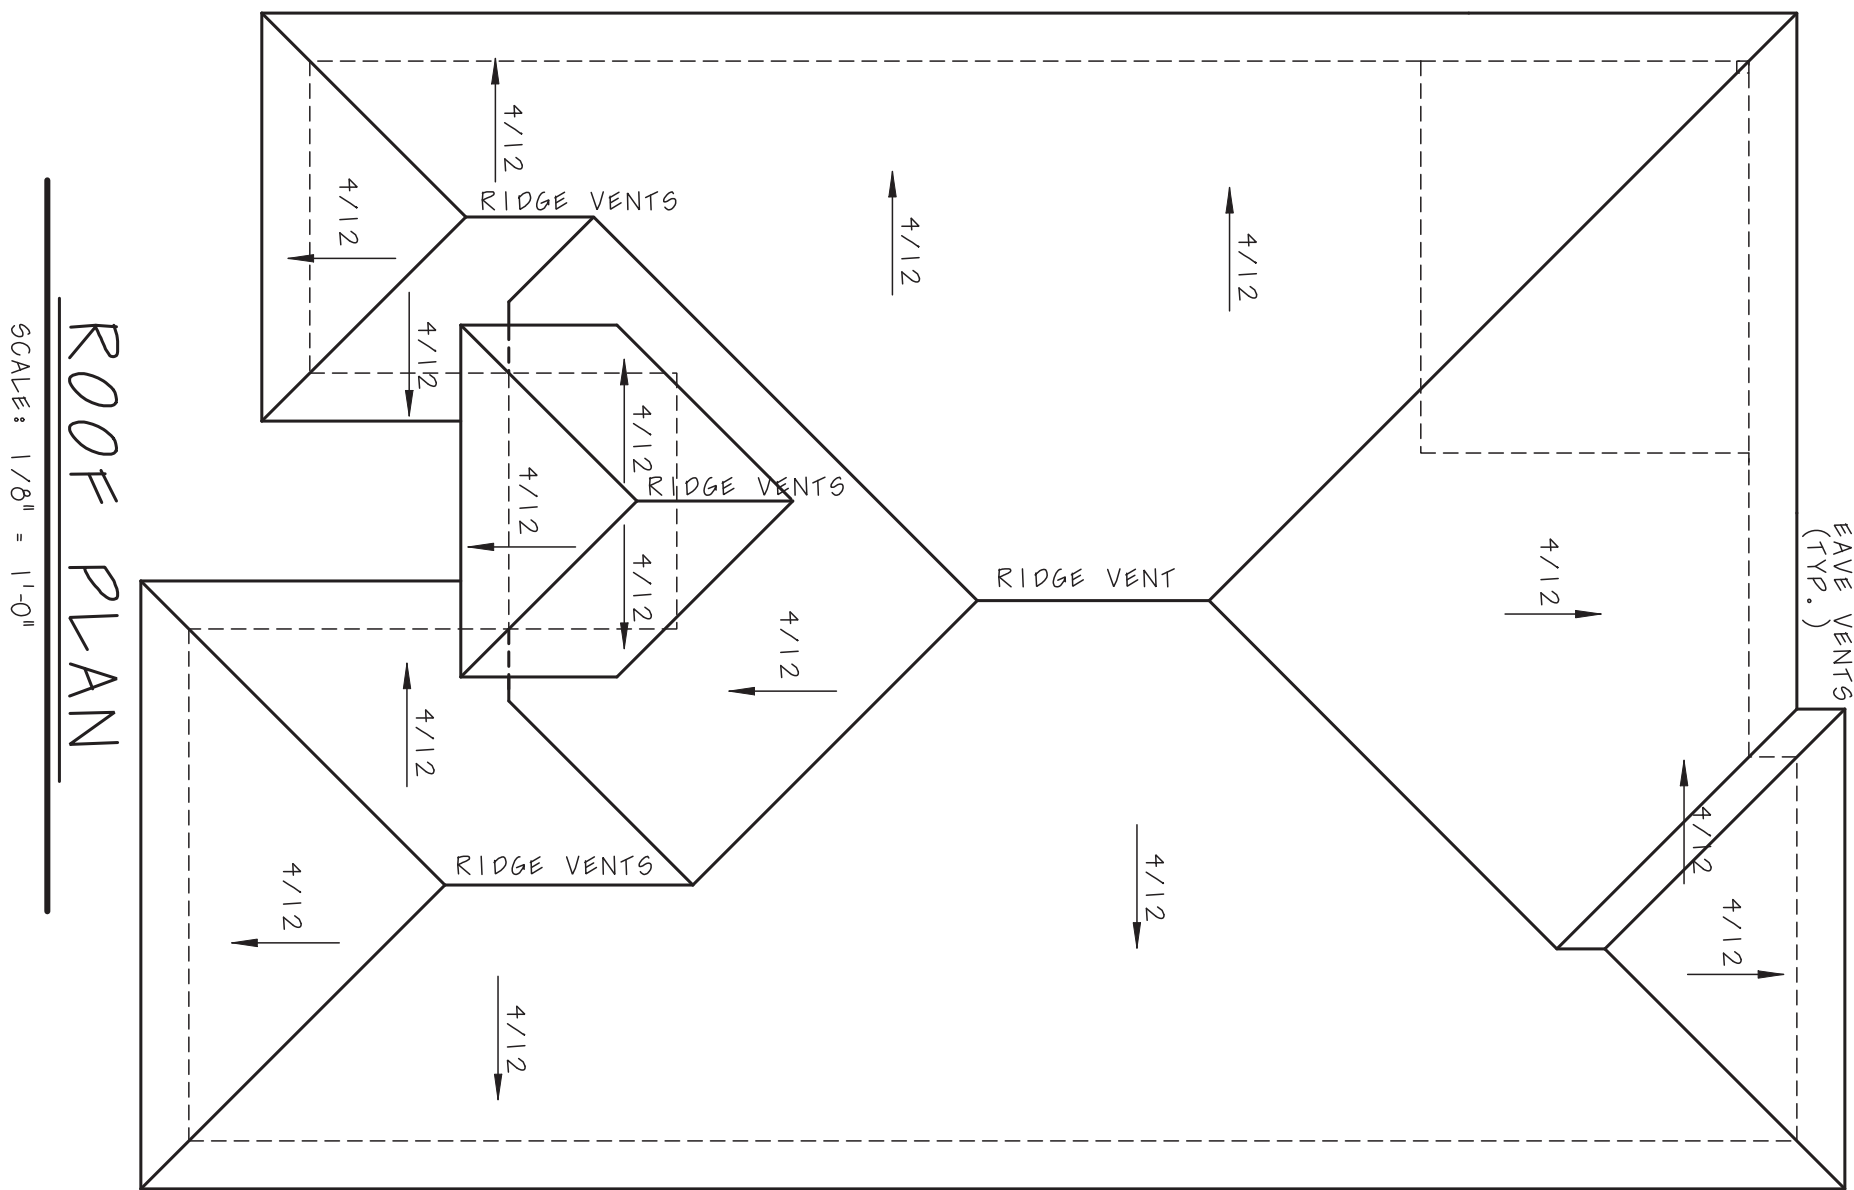
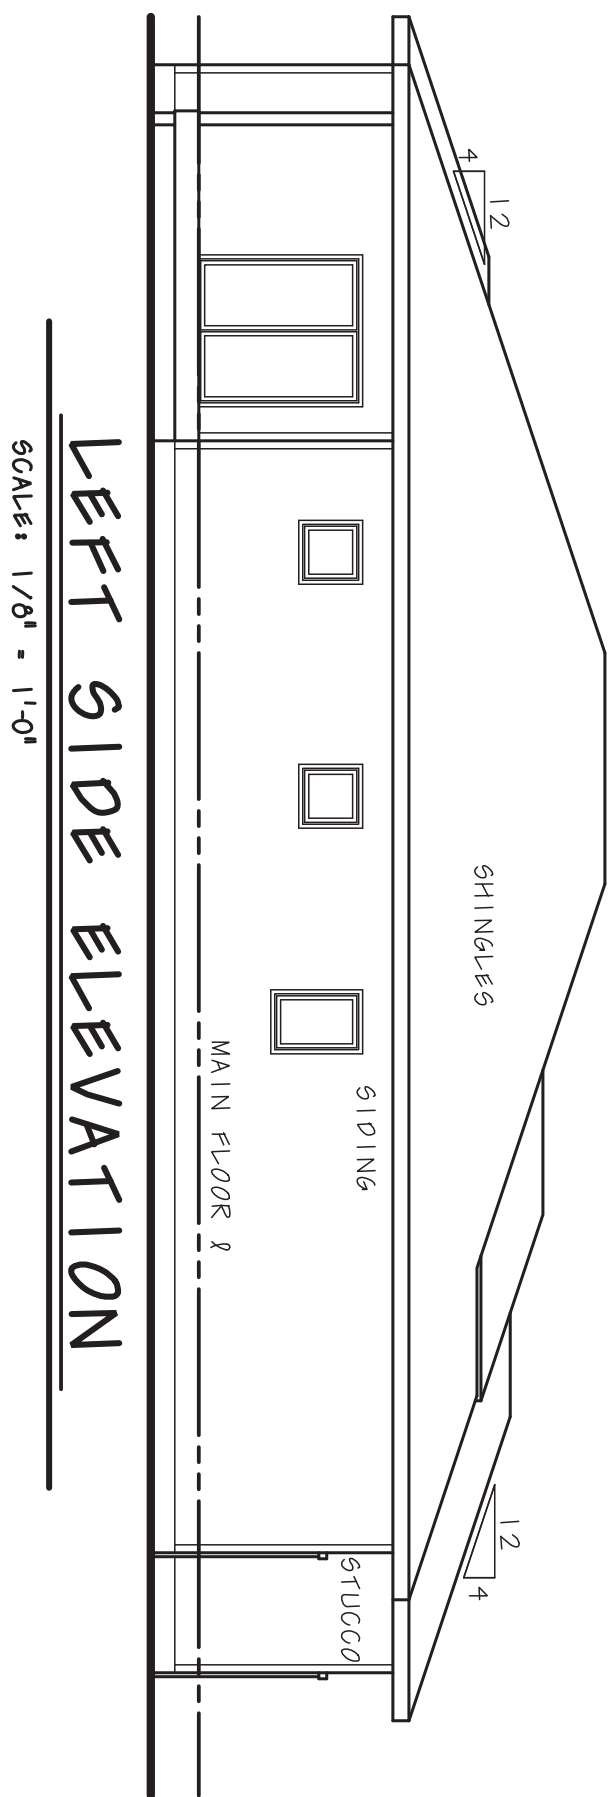
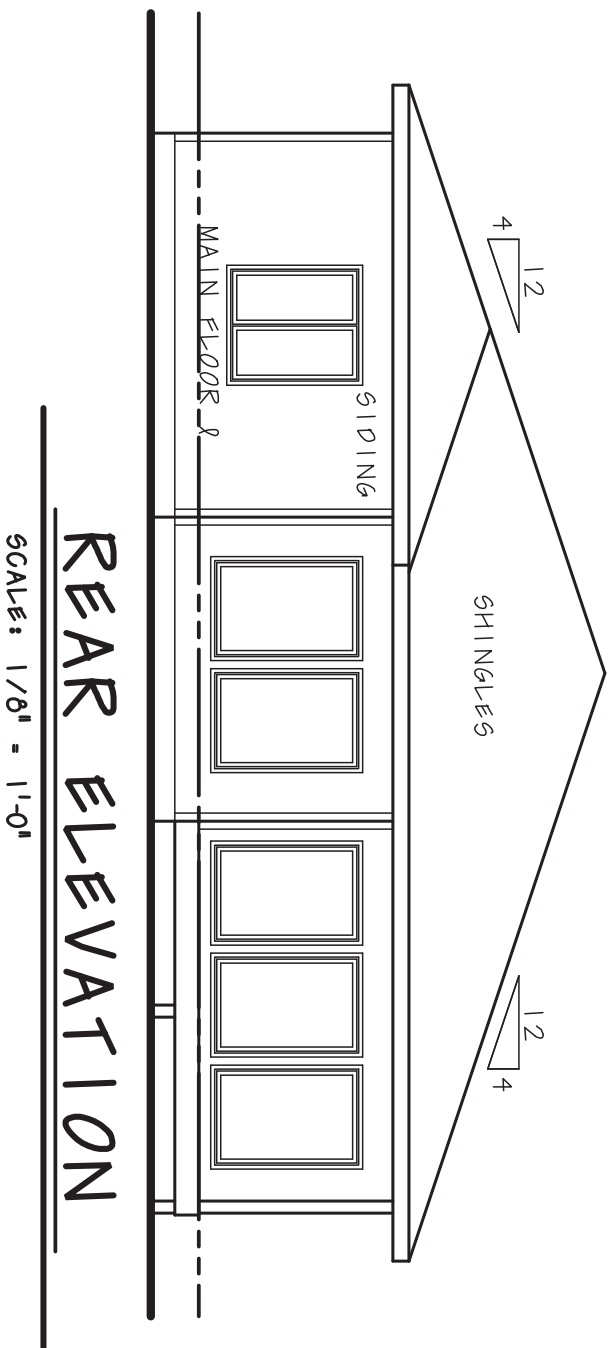
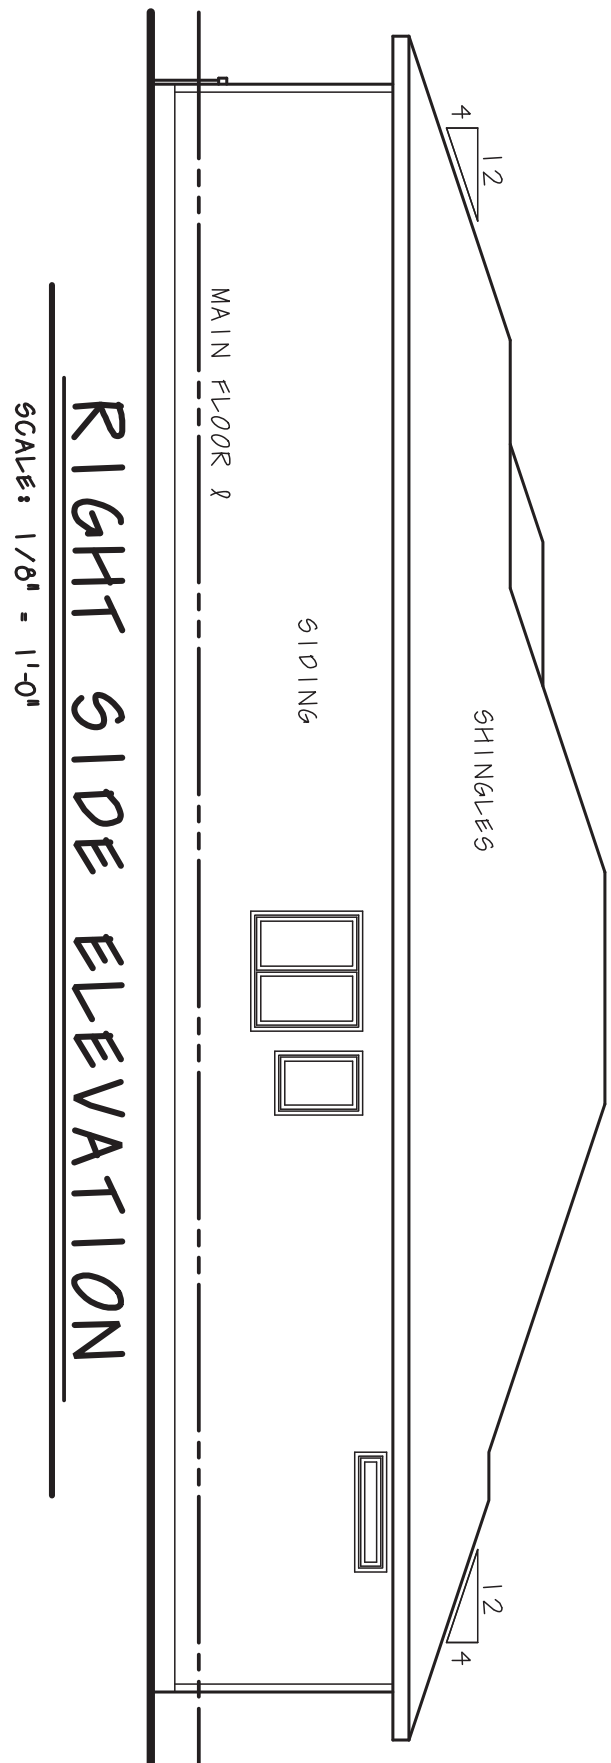


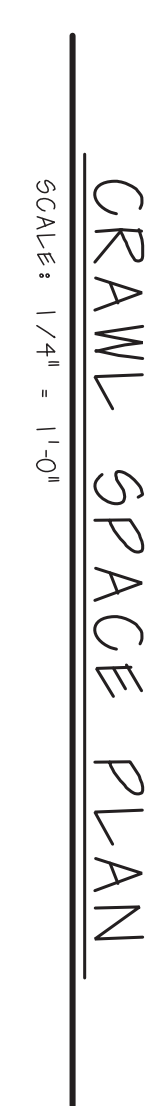

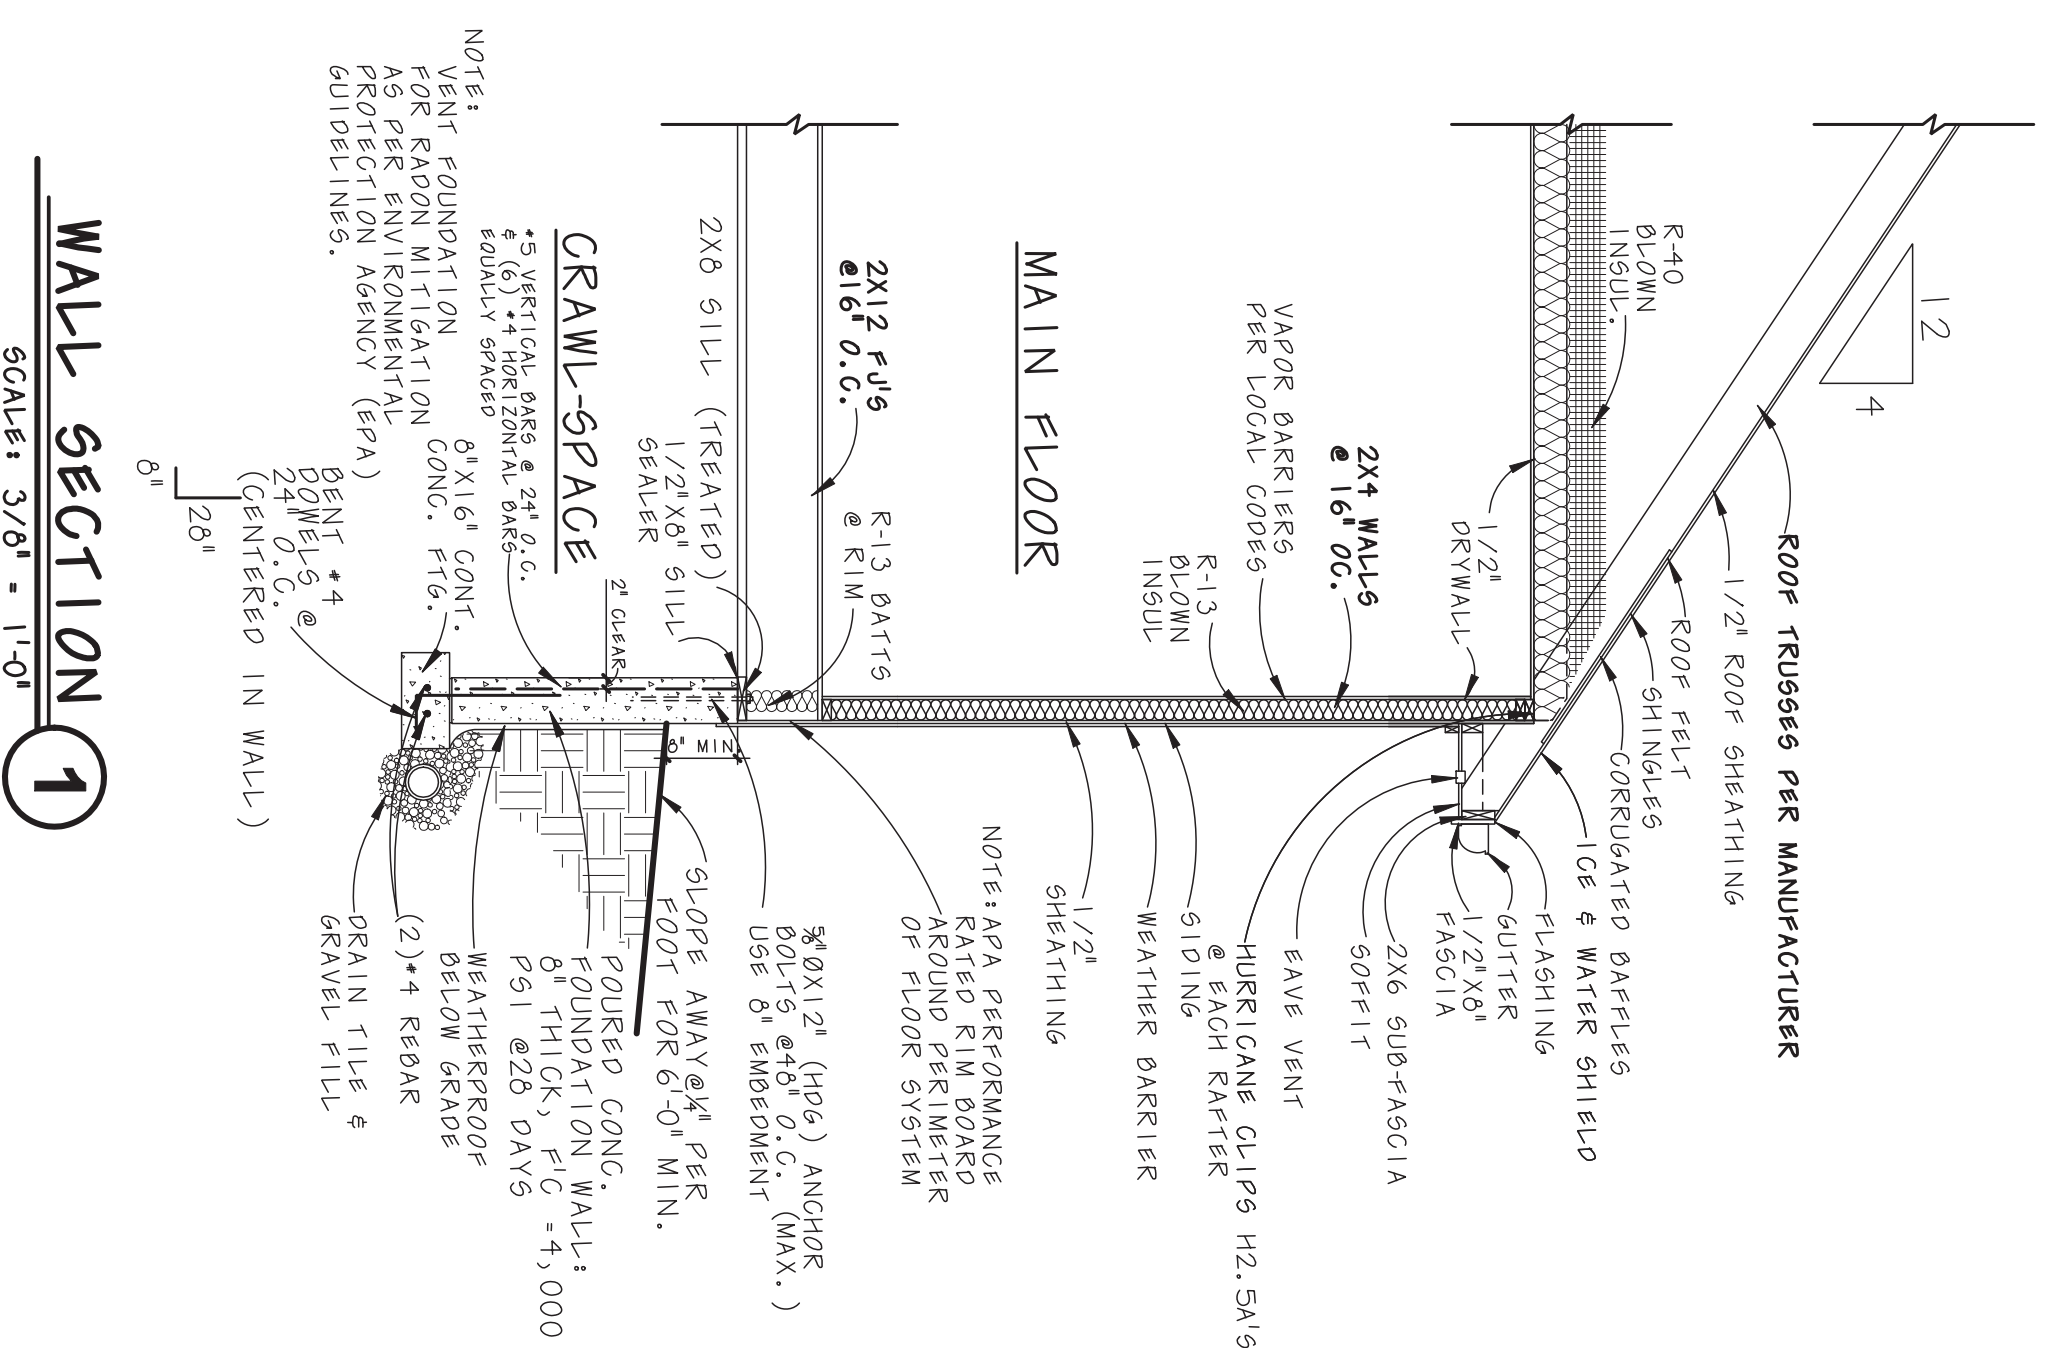


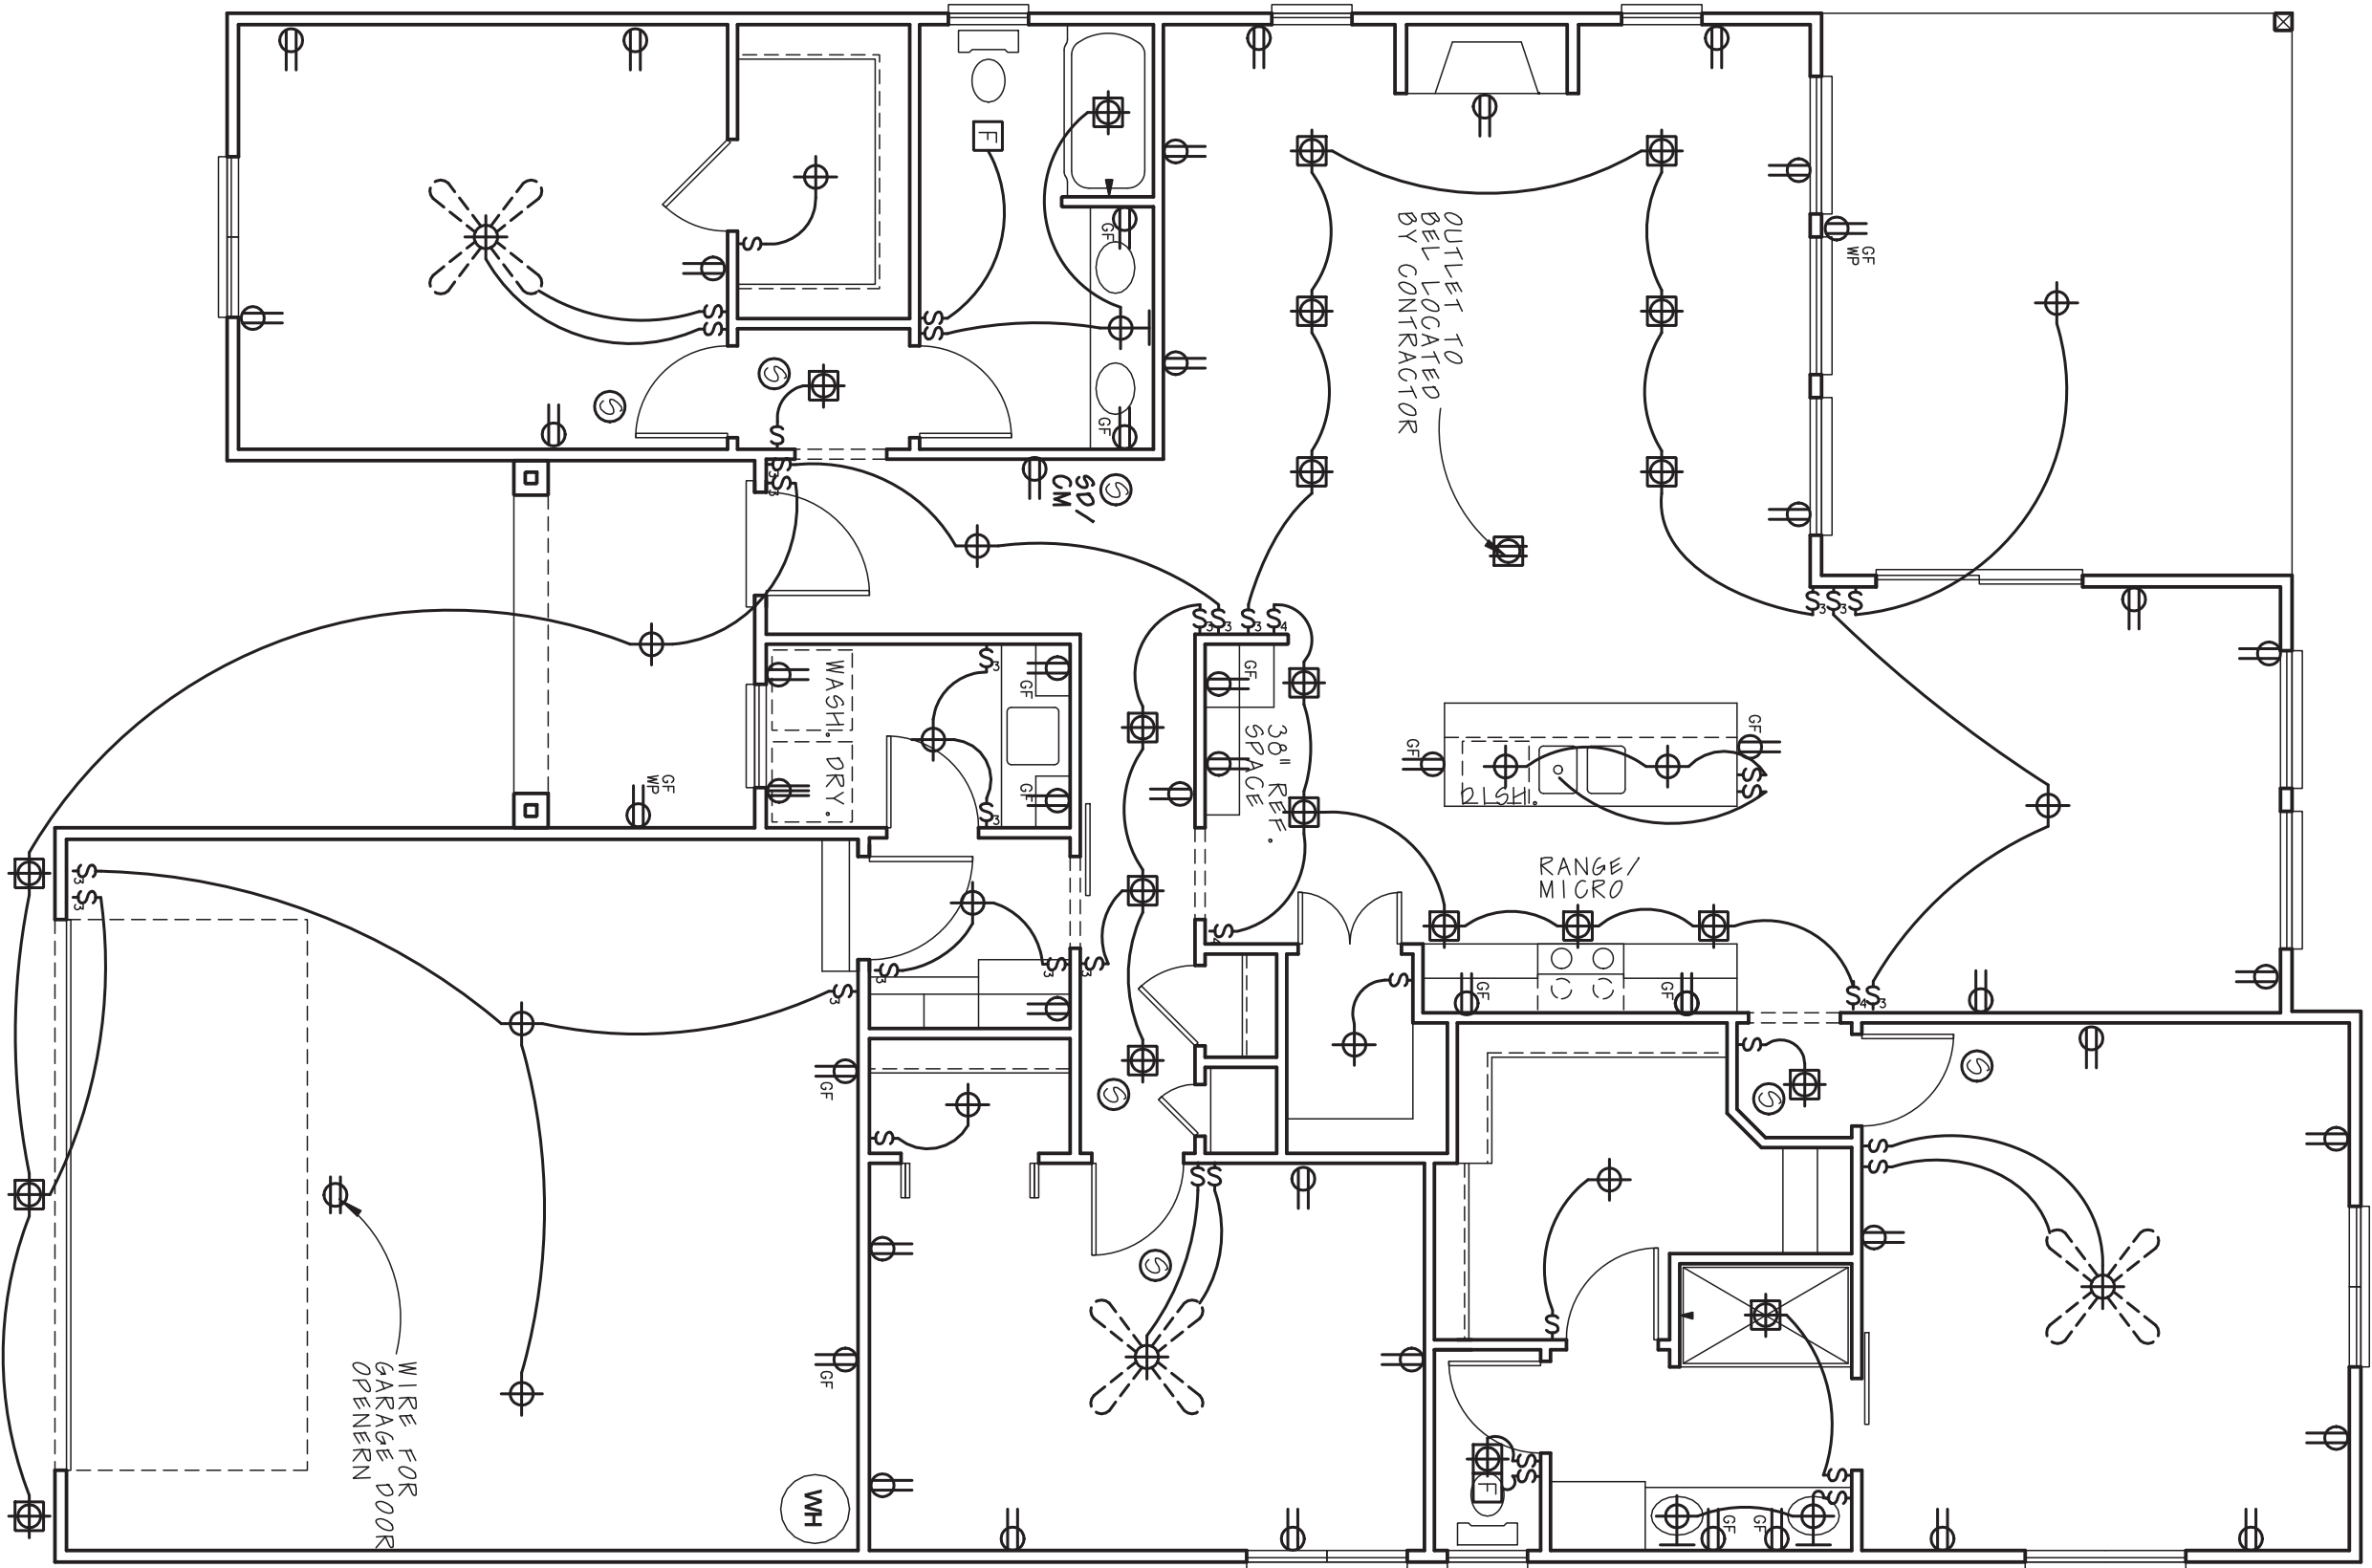

MAIN LEVEL ELECTRICAL
SCALE: 3/16" = 1'-0"

GENERAL ELECTRICAL LEGEND	
SYMBOL	DESCRIPTION
	110 V. OUTLET
	HALF SWITCHED 110 V. OUTLET
	220 V. OUTLET
	KITCHEN/REAR 110 V. OUTLET
	GROUND FAULT 110 V. OUTLET
	FLOOR 110 V. OUTLET
	SURFACE MOUNT LIGHT
	RECESSED CAN LIGHT
	WALL MOUNT LIGHT
	PULL-CORD SURFACE MOUNT LIGHT
	PADDLE FAN
	SMOKE DETECTOR (WALL)
	SMOKE DETECTOR (CEILING)
	CHIMNEY
	THERMOSTAT
	HEAT LAMP
	FLOOD LIGHT
	FLUORESCENT LIGHT
	TRACK LIGHT
	UNDER COUNTER LIGHT
	EXHAUST FAN
	EXHAUST FAN/LIGHT COMB.
	PADDLE FAN/LIGHT FIXTURE
	SMOKE DETECTOR (WALL)
	SMOKE DETECTOR (CEILING)
	TWO-WAY SWITCH
	THREE-WAY SWITCH
	FOUR-WAY SWITCH

NOTE: WIRE SMOKE DETECTORS IN SERIES

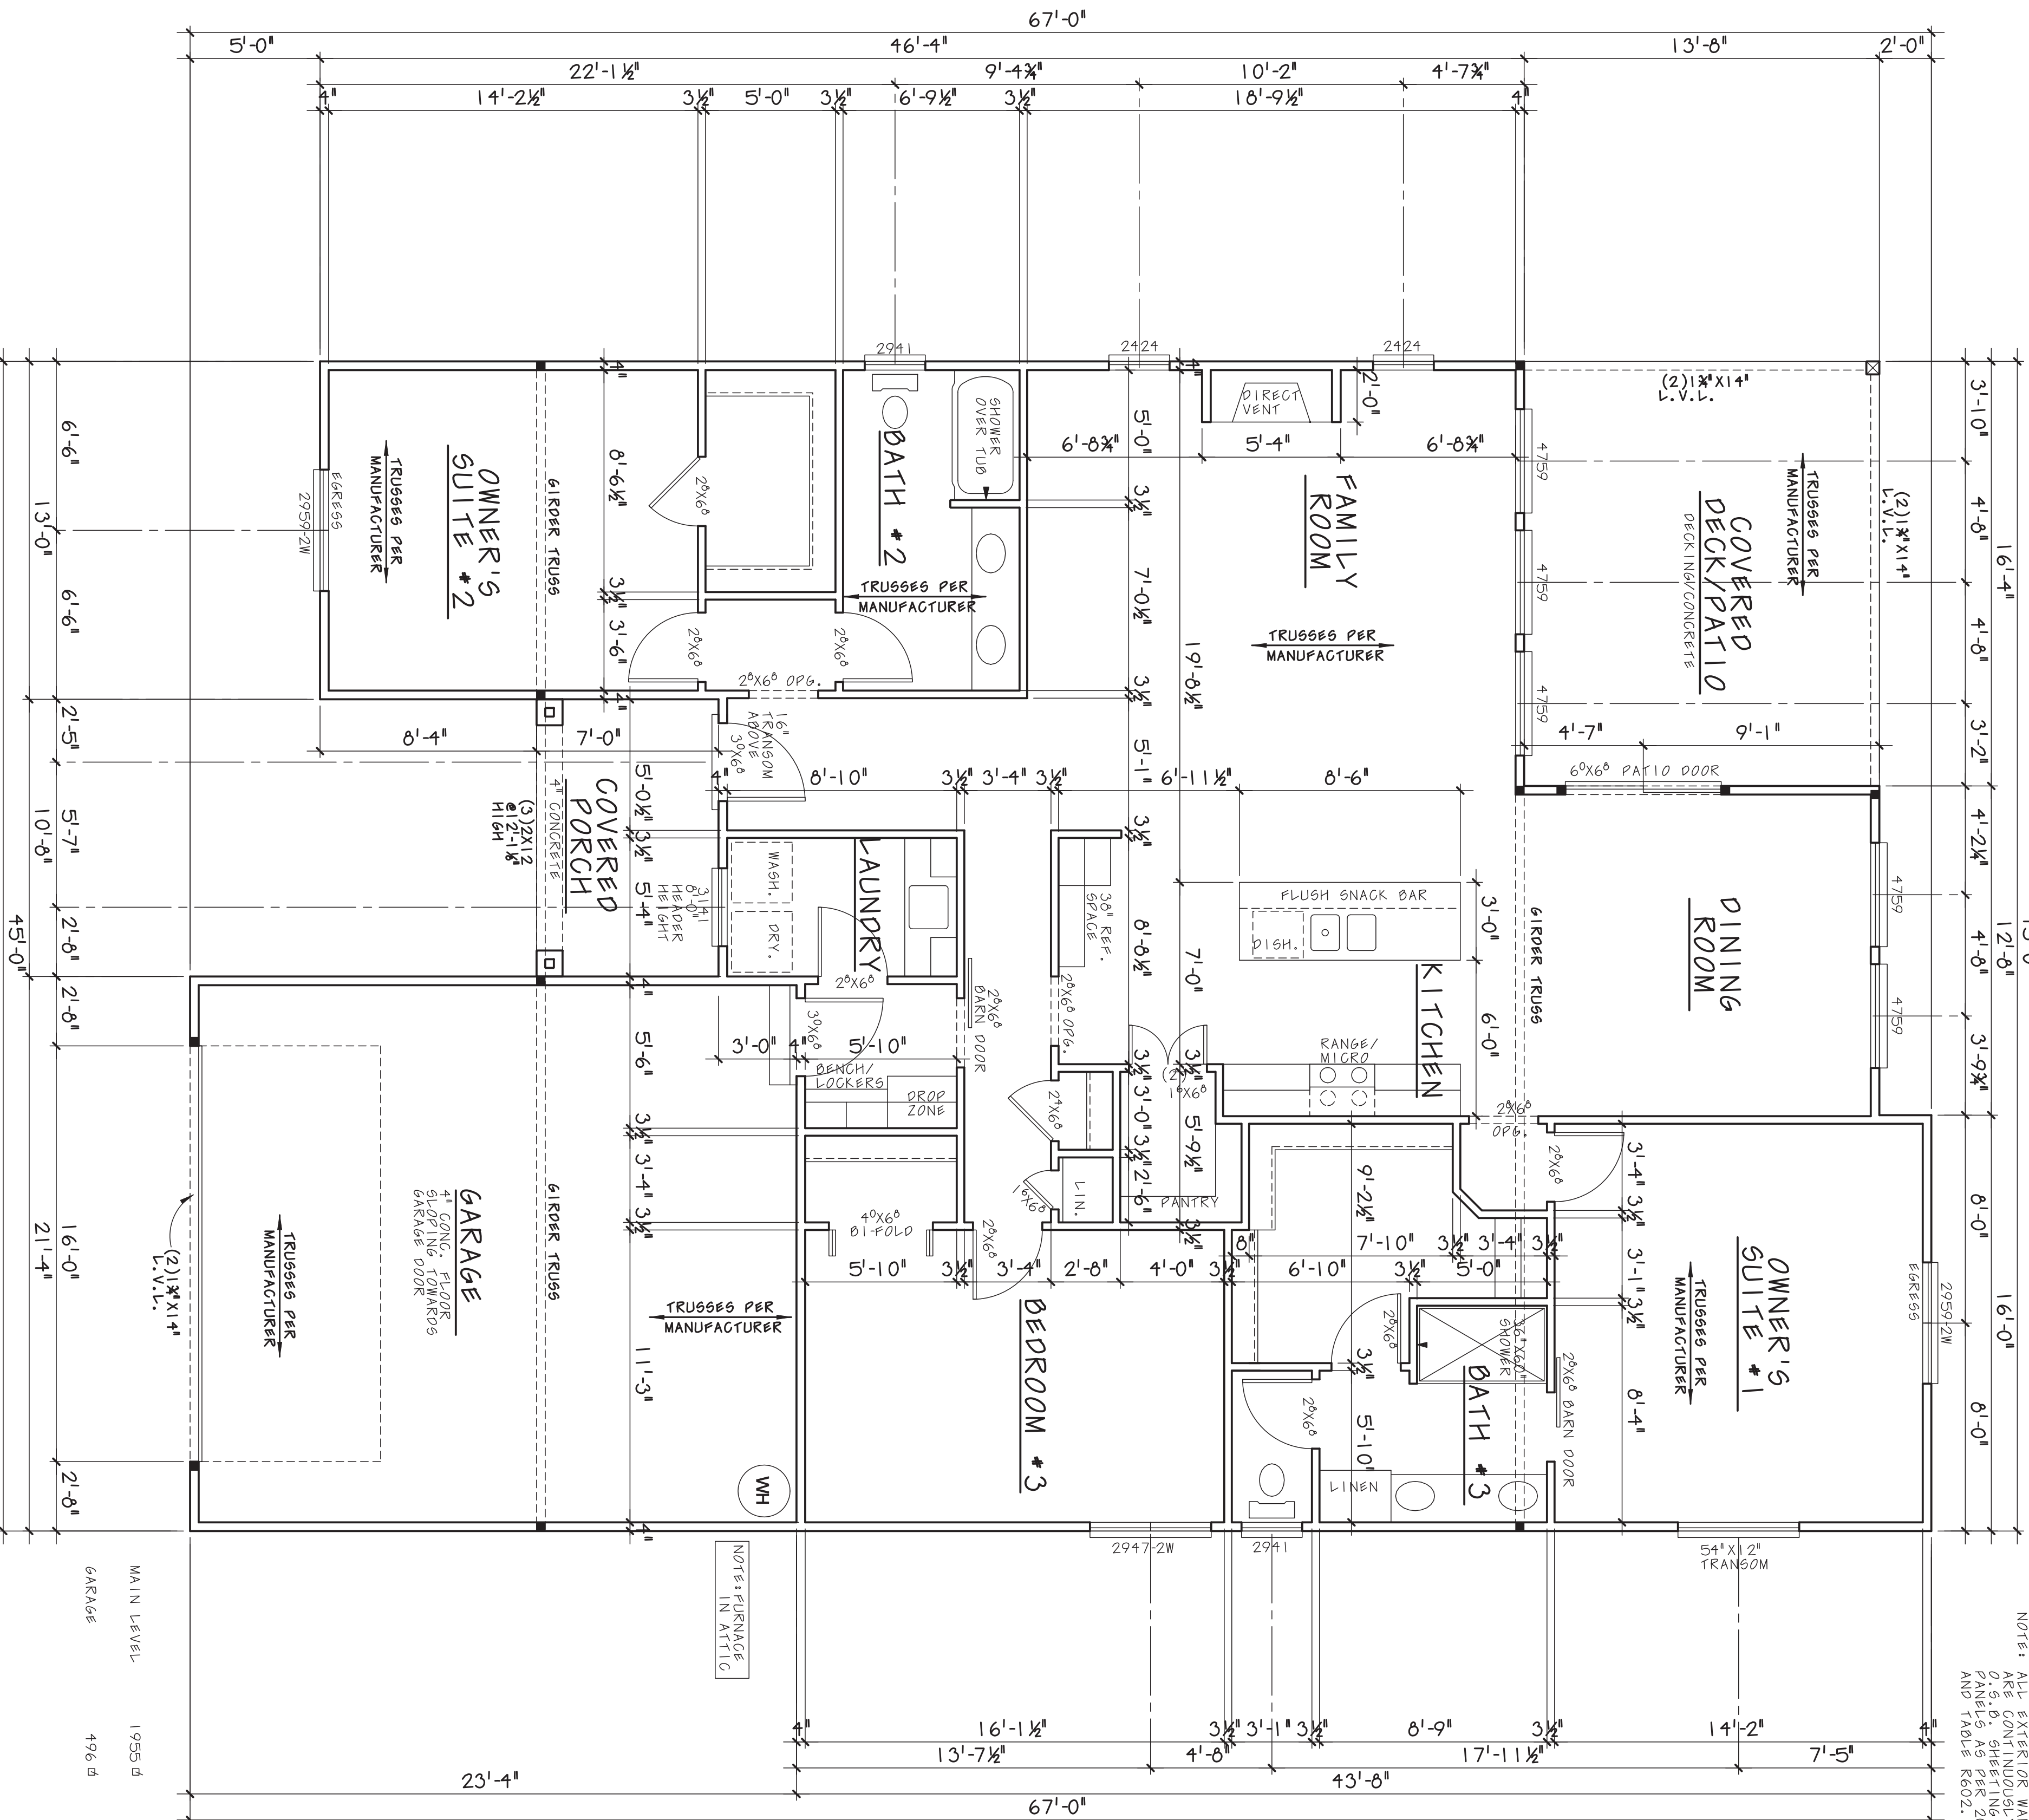

MAIN LEVEL FLOOR PLAN
SCALE: 1/4" = 1'-0"

- NOTES:
- ALL EXTERIOR WALLS ARE 4" (3) STUD - 2" SHEATHING. ALL INTERIOR WALLS ARE 5/8" UNLESS OTHERWISE SHOWN.
 - ALL MAIN FLOOR WALLS ARE 8" UNLESS OTHERWISE SHOWN.
 - ALL ANGLED WALLS ARE @ 45°.
 - ALL LVL'S ARE 1.9E OR BETTER.
 - ALL EXTERIOR WALLS ARE CONTINUOUSLY SHEATHED WITH 0.5" O.S.B. SHEATHING. BRICKED WALL PANELS AS PER 2010 IRC R601.2 AND TABLE R602.10.5.

NOTES: FINISHES IN ATTIC

DESIGN BASICS, LLC IS A PROFESSIONAL RESIDENTIAL DESIGN FIRM LOCATED IN OMAHA, NE. BECAUSE SITE CONDITIONS MAY VARY DESIGN BASICS, LLC CANNOT WARRANT THE SUITABILITY OF THESE PLANS FOR USE ON YOUR SPECIFIC SITE. CONSTRUCTION FROM THESE PLANS SHOULD NOT BE UNDERTAKEN WITHOUT THE ASSISTANCE OF A CONSTRUCTION PROFESSIONAL.

DESIGN BASICS, LLC
...WHERE GREAT DESIGN MATTERS
www.designbasics.com

THE PURCHASER OF THESE PLANS IS GIVEN A LIMITED LICENSE TO REPRODUCE THESE PLANS FOR CONSTRUCTION PURPOSES ONLY AND FURTHER DISTRIBUTION IS STRICTLY PROHIBITED.

REVERSE AVAILABLE

1112 John Galt Blvd.
Omaha, NE 68137
Toll Free: (800) 947-7526
Fax: (402) 331-5507

ALL PLANS
CONTAINED
HEREIN

CC-109310
42461

© 2019

SHEET
4 of 4