


DOOR SCHEDULE


DOOR SIZE	DESCRIPTION	ELECTRICAL SCHEDULE
1 2' 0" x 7' 0" x 1 3/4"	SEE ELEVATION	CEILING OUTLET
2 2' 8" x 7' 0" x 1 3/4"	SEE ELEVATION	WALL BRACKET OPERATED BY PULL SWITCH
3 2' 0" x 7' 0" x 1 3/4"	SEE ELEVATION	DIRECT RECEPTACLE
4 2' 8" x 6' 8" x 1 3/4"	FLUSH VENEER	COMBINATION WALL BRACKET & RECEPT
5 2' 0" x 6' 8" x 1 3/4"	FLUSH VENEER	RANGE WITH HEIGHT ABOVE FLOOR INDICATED
6 2' 0" x 6' 8" x 1 3/4"	FLUSH VENEER	RANGE OUTLET
7 2' 0" x 6' 8" x 1 3/4"	FLUSH VENEER	HEAVY OUTLET
8 2' 0" x 6' 8" x 1 3/4"	FLUSH VENEER	SINGLE POLE WALL SWITCH
9 2' 0" x 6' 8" x 1 3/4"	FLUSH VENEER	3-WAY WALL SWITCH
10 2' 0" x 6' 8" x 1 3/4"	FLUSH VENEER	CALL BUTTON
11 2' 0" x 6' 8" x 1 3/4"	FLUSH VENEER	CHIMES

ELECTRICAL SCHEDULE

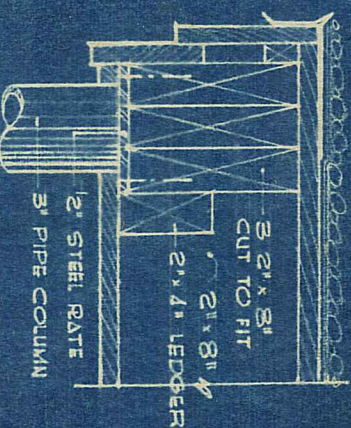

PIPE COLUMN DETAIL
SCALE: 1/2" = 1' 0"

PLAN
REPLACE DETAILS
SCALE: 2" = 1' 0"

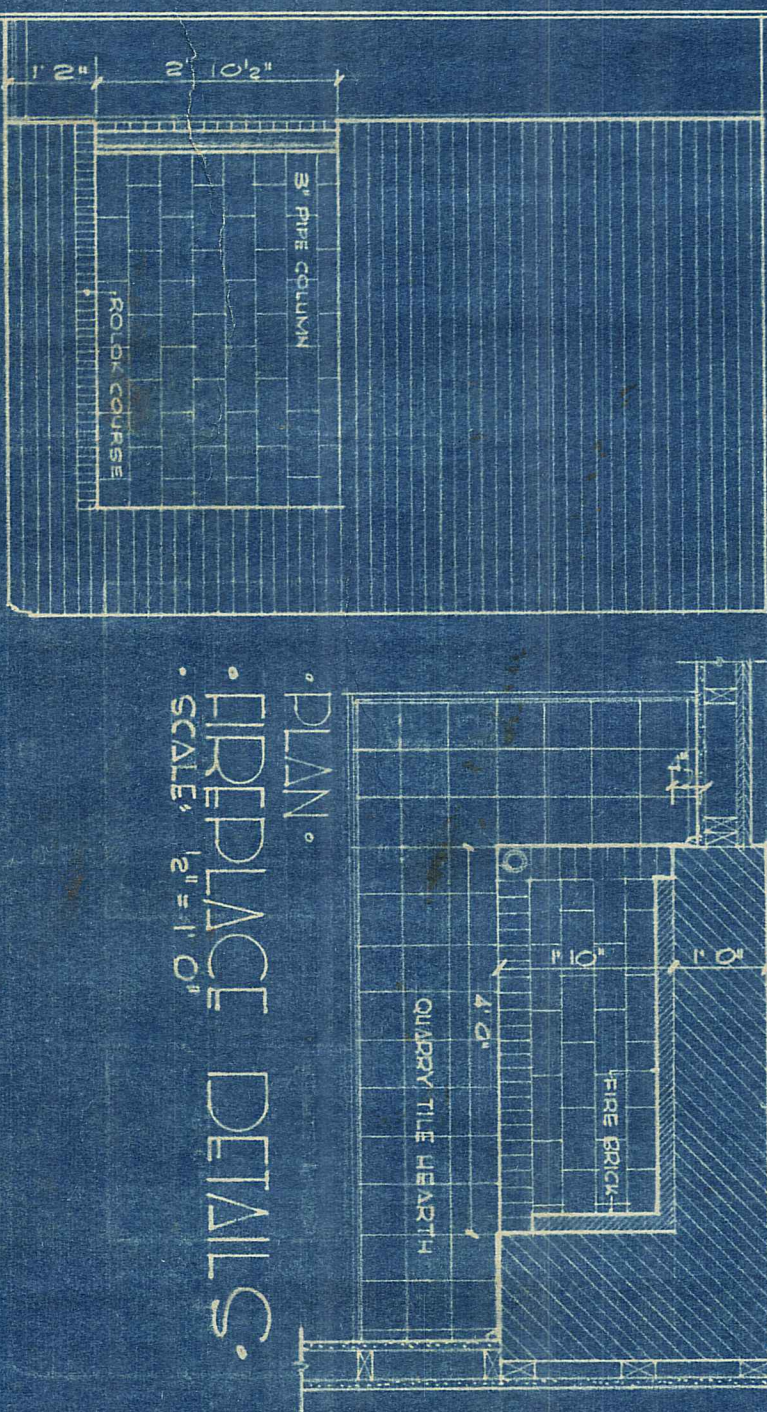


ELEVATION

ROOM FINISH SCHEDULE

ROOM	FLOOR	BASE	WALLS	CEILING	WAINSCOT	REMARKS
LIVING	WOOD	WOOD	PLASTER	PLASTER		
DINING	WOOD	WOOD	PLASTER	PLASTER		
KITCHEN	WOOD	WOOD	PLASTER	PLASTER		
BED ROOM #1	WOOD	WOOD	PLASTER	PLASTER		
BED ROOM #2	WOOD	WOOD	PLASTER	PLASTER		
BED ROOM #3	WOOD	WOOD	PLASTER	PLASTER		
BATH #1	WOOD	WOOD	PLASTER	PLASTER		
BATH #2	WOOD	WOOD	PLASTER	PLASTER		
BATH #3	WOOD	WOOD	PLASTER	PLASTER		
CLOSET	WOOD	WOOD	PLASTER	PLASTER		
HALL	WOOD	WOOD	PLASTER	PLASTER		
ENTRY	WOOD	WOOD	PLASTER	PLASTER		
REAR PORCH	WOOD	WOOD	PLASTER	PLASTER		
FRONT PORCH	WOOD	WOOD	PLASTER	PLASTER		

These drawings are instruments of service and as such are the property of the Architect. Upon completion of the work all drawings except the Contract copies are to be returned to the Architect.

ELEVATION
SCALE: 2" = 1' 0"

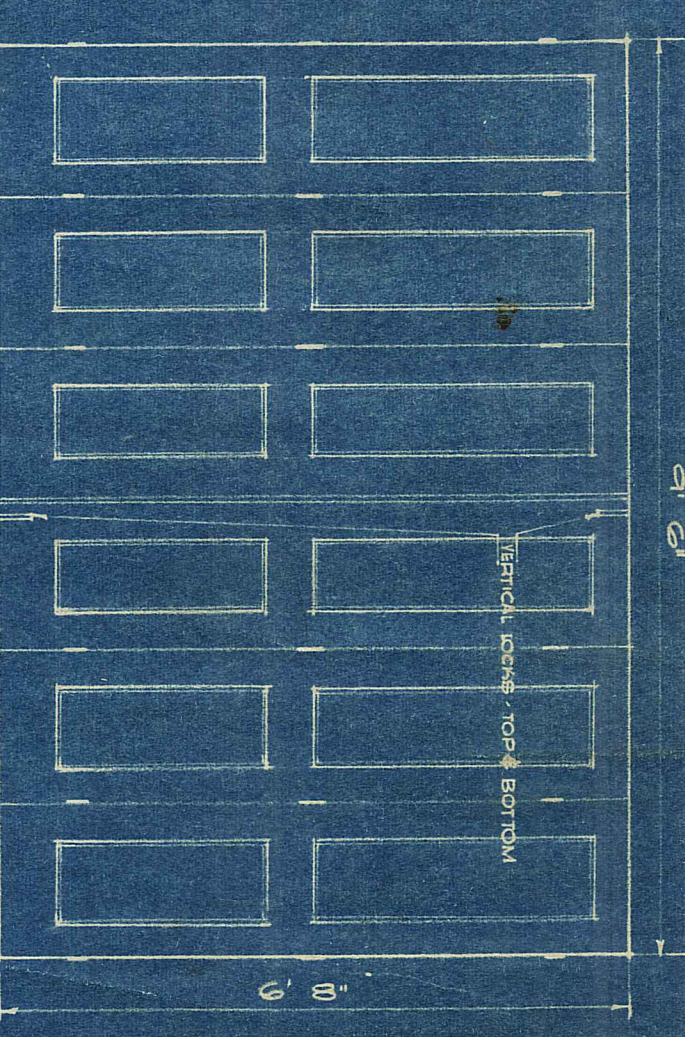


PLAN
SCALE: 1" = 1' 0"

FOLDING DOOR DETAILS
(FOR APT KITCHEN)



FLOOR PLAN
SCALE: 1/4" = 1' 0"

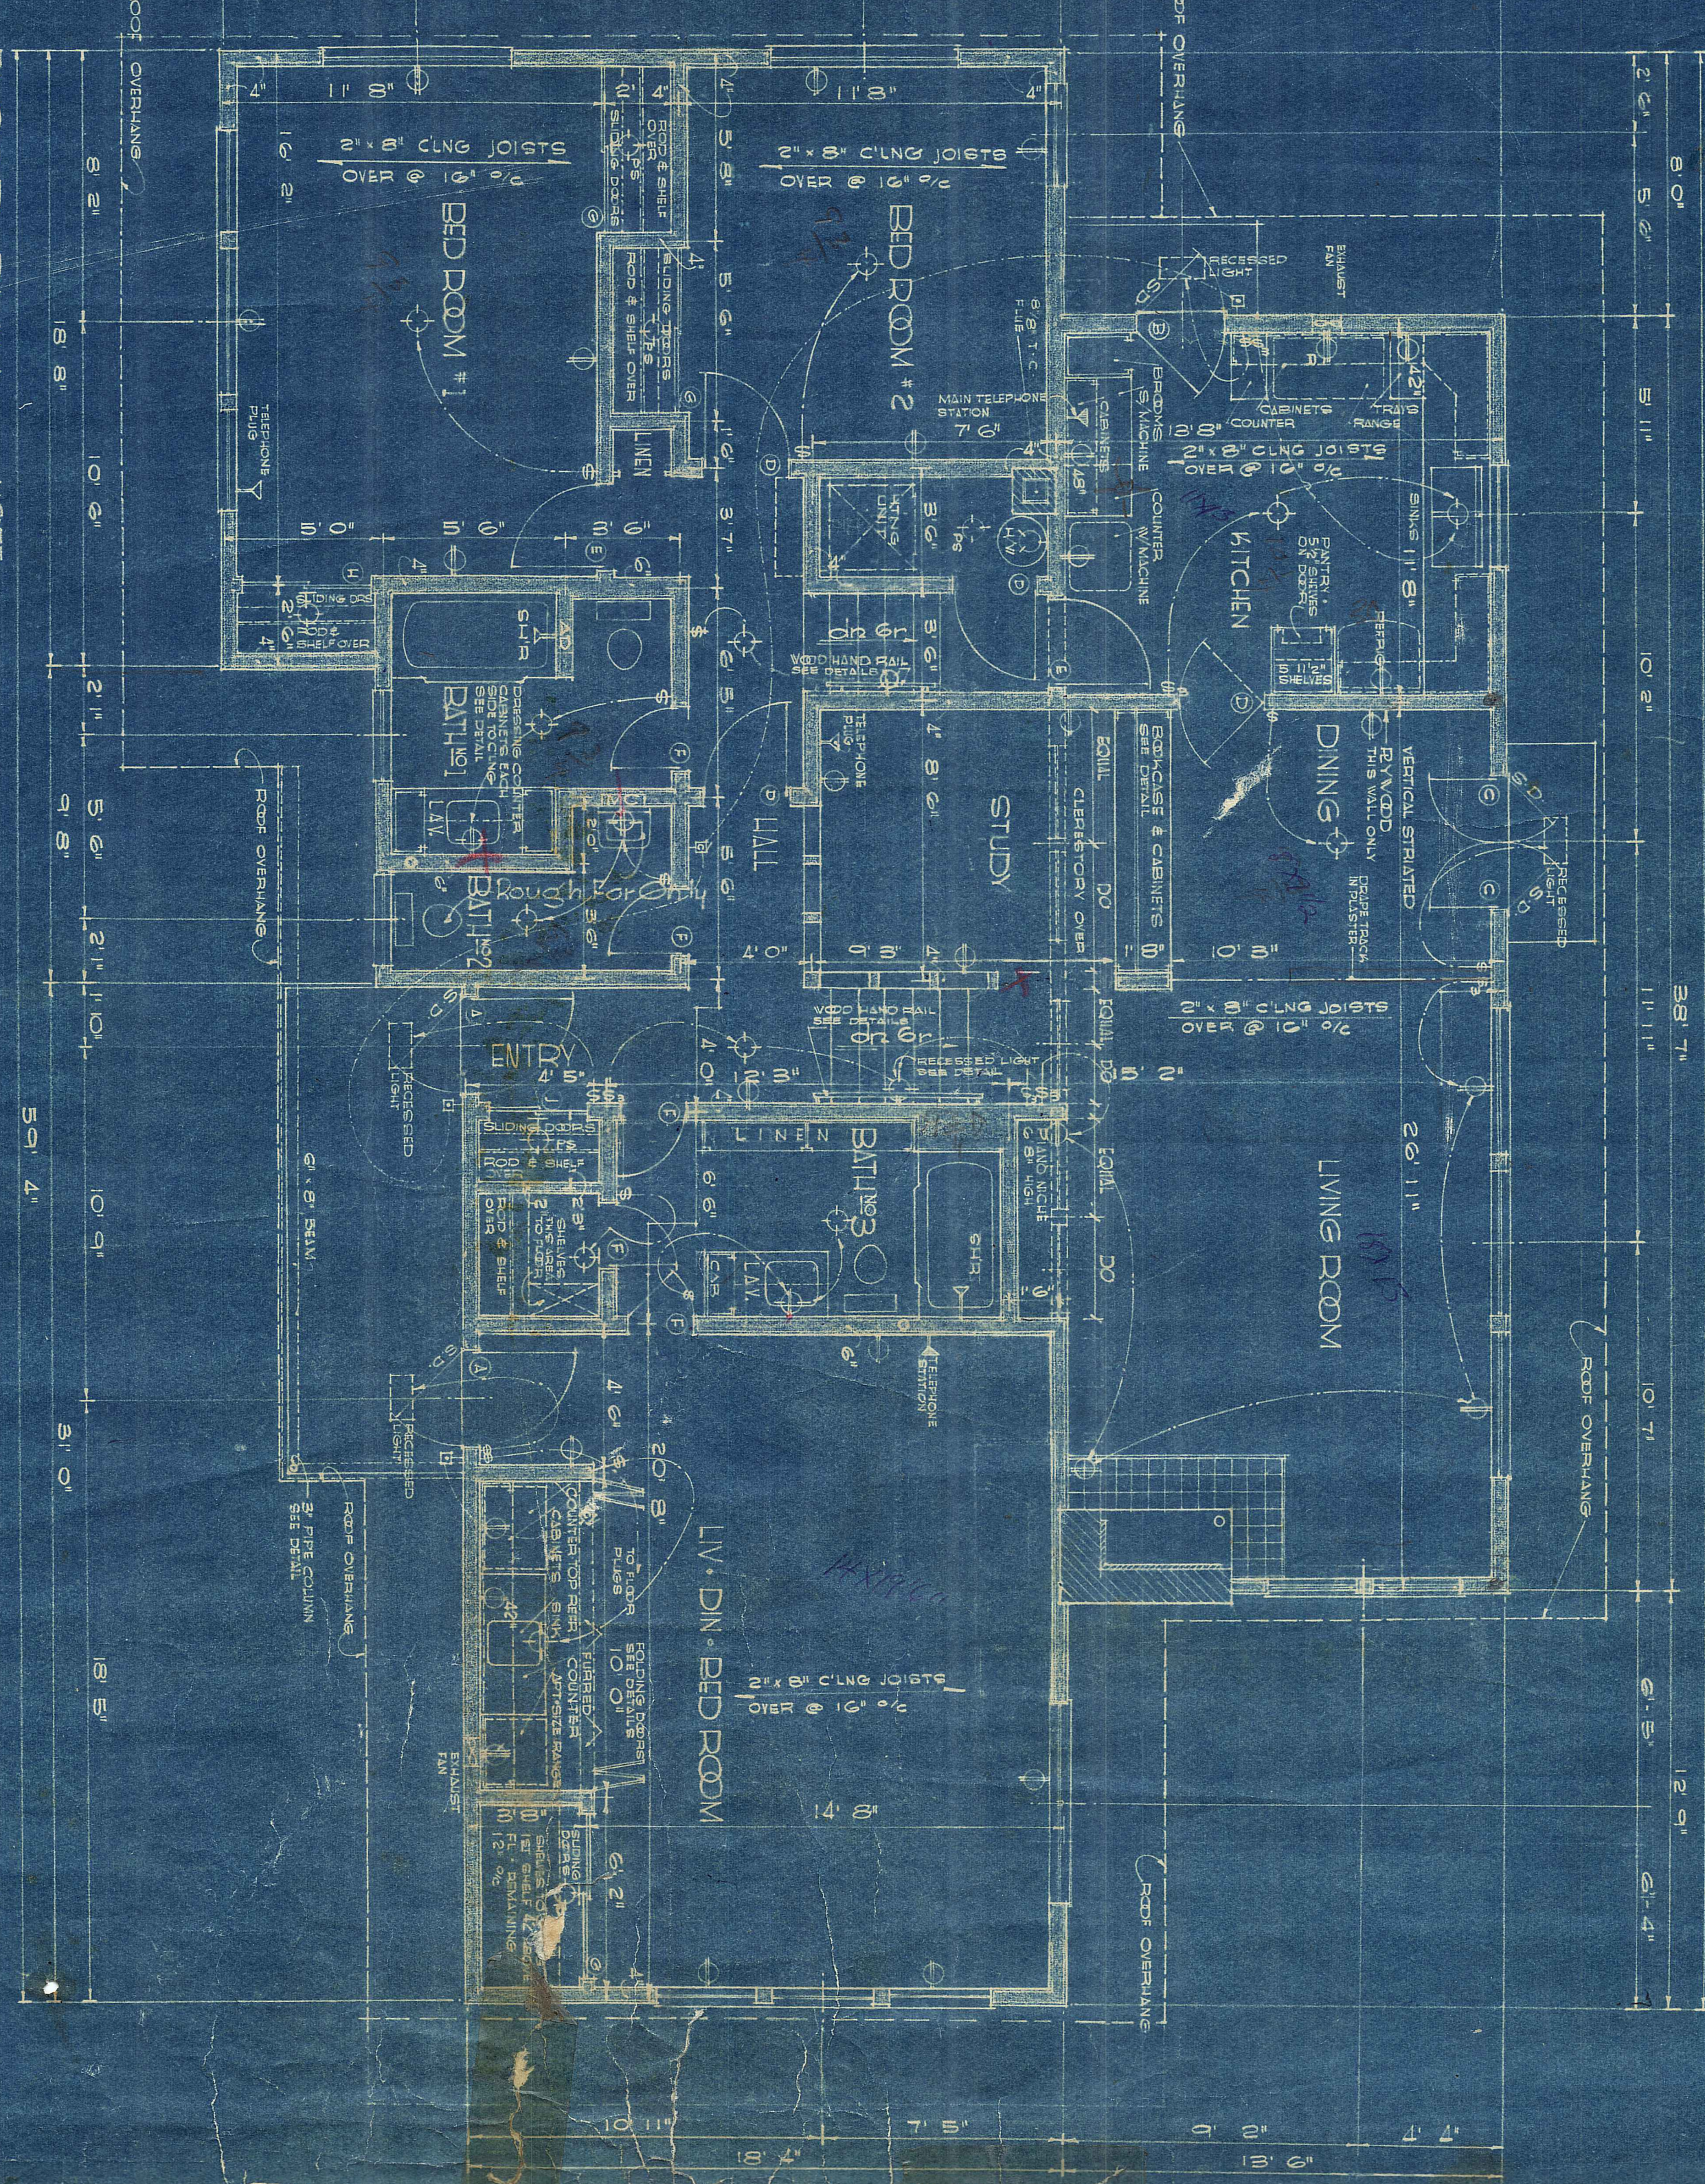

NOTE:
ALL CEILING OUTLETS TO BE RECESSED
DO NOT PLACE RAFTERS CLOSER THAN 6" FROM ROOM CENTER

NOTE:
ROOM DIMENSIONS ARE SHOWN TO THE CENTER OF ALL INTERIOR WALL PLATES & TO THE OUTSIDE OF ALL EXTERIOR WALL PLATES. ALL PARTITIONS ARE OF 2" STUDS EXCEPT WHERE NOTED DIFFERENTLY

LEGER RESIDENCE
Raleigh, North Carolina

HOLLOWAY, WEBER and REEVES
ARCHITECTS
Raleigh, North Carolina

JUL 21 1950
APR 8 1950
Taylor